



Public Address System

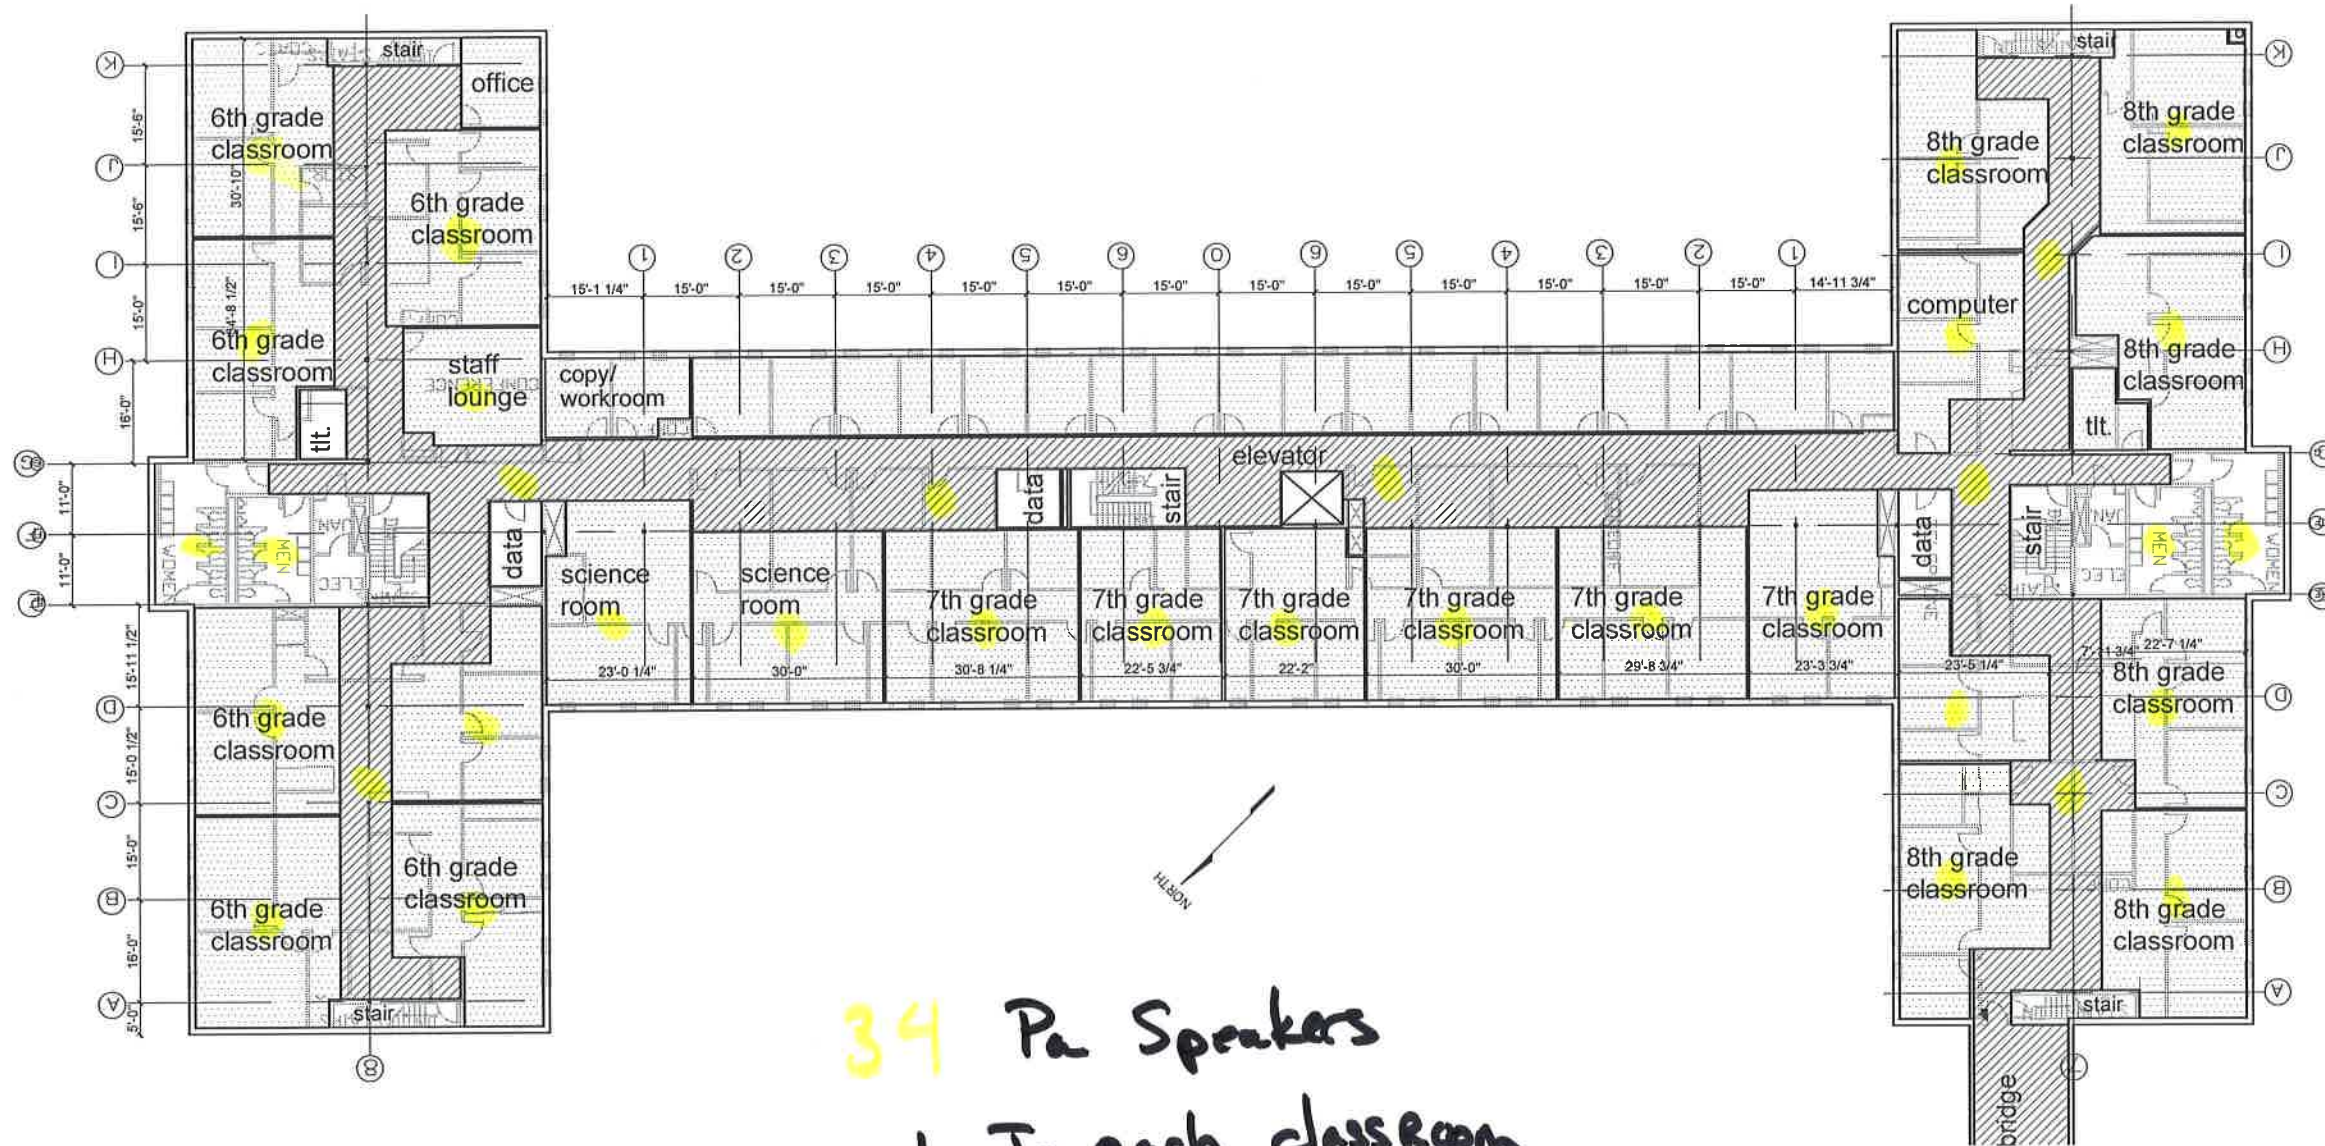

34 Pa Speakers
 1 In each classroom
 wired to main office

SECOND FLOOR PLAN
 SCALE: 1" = 30'-0"
 0 15' 30' 60'

Public Address System

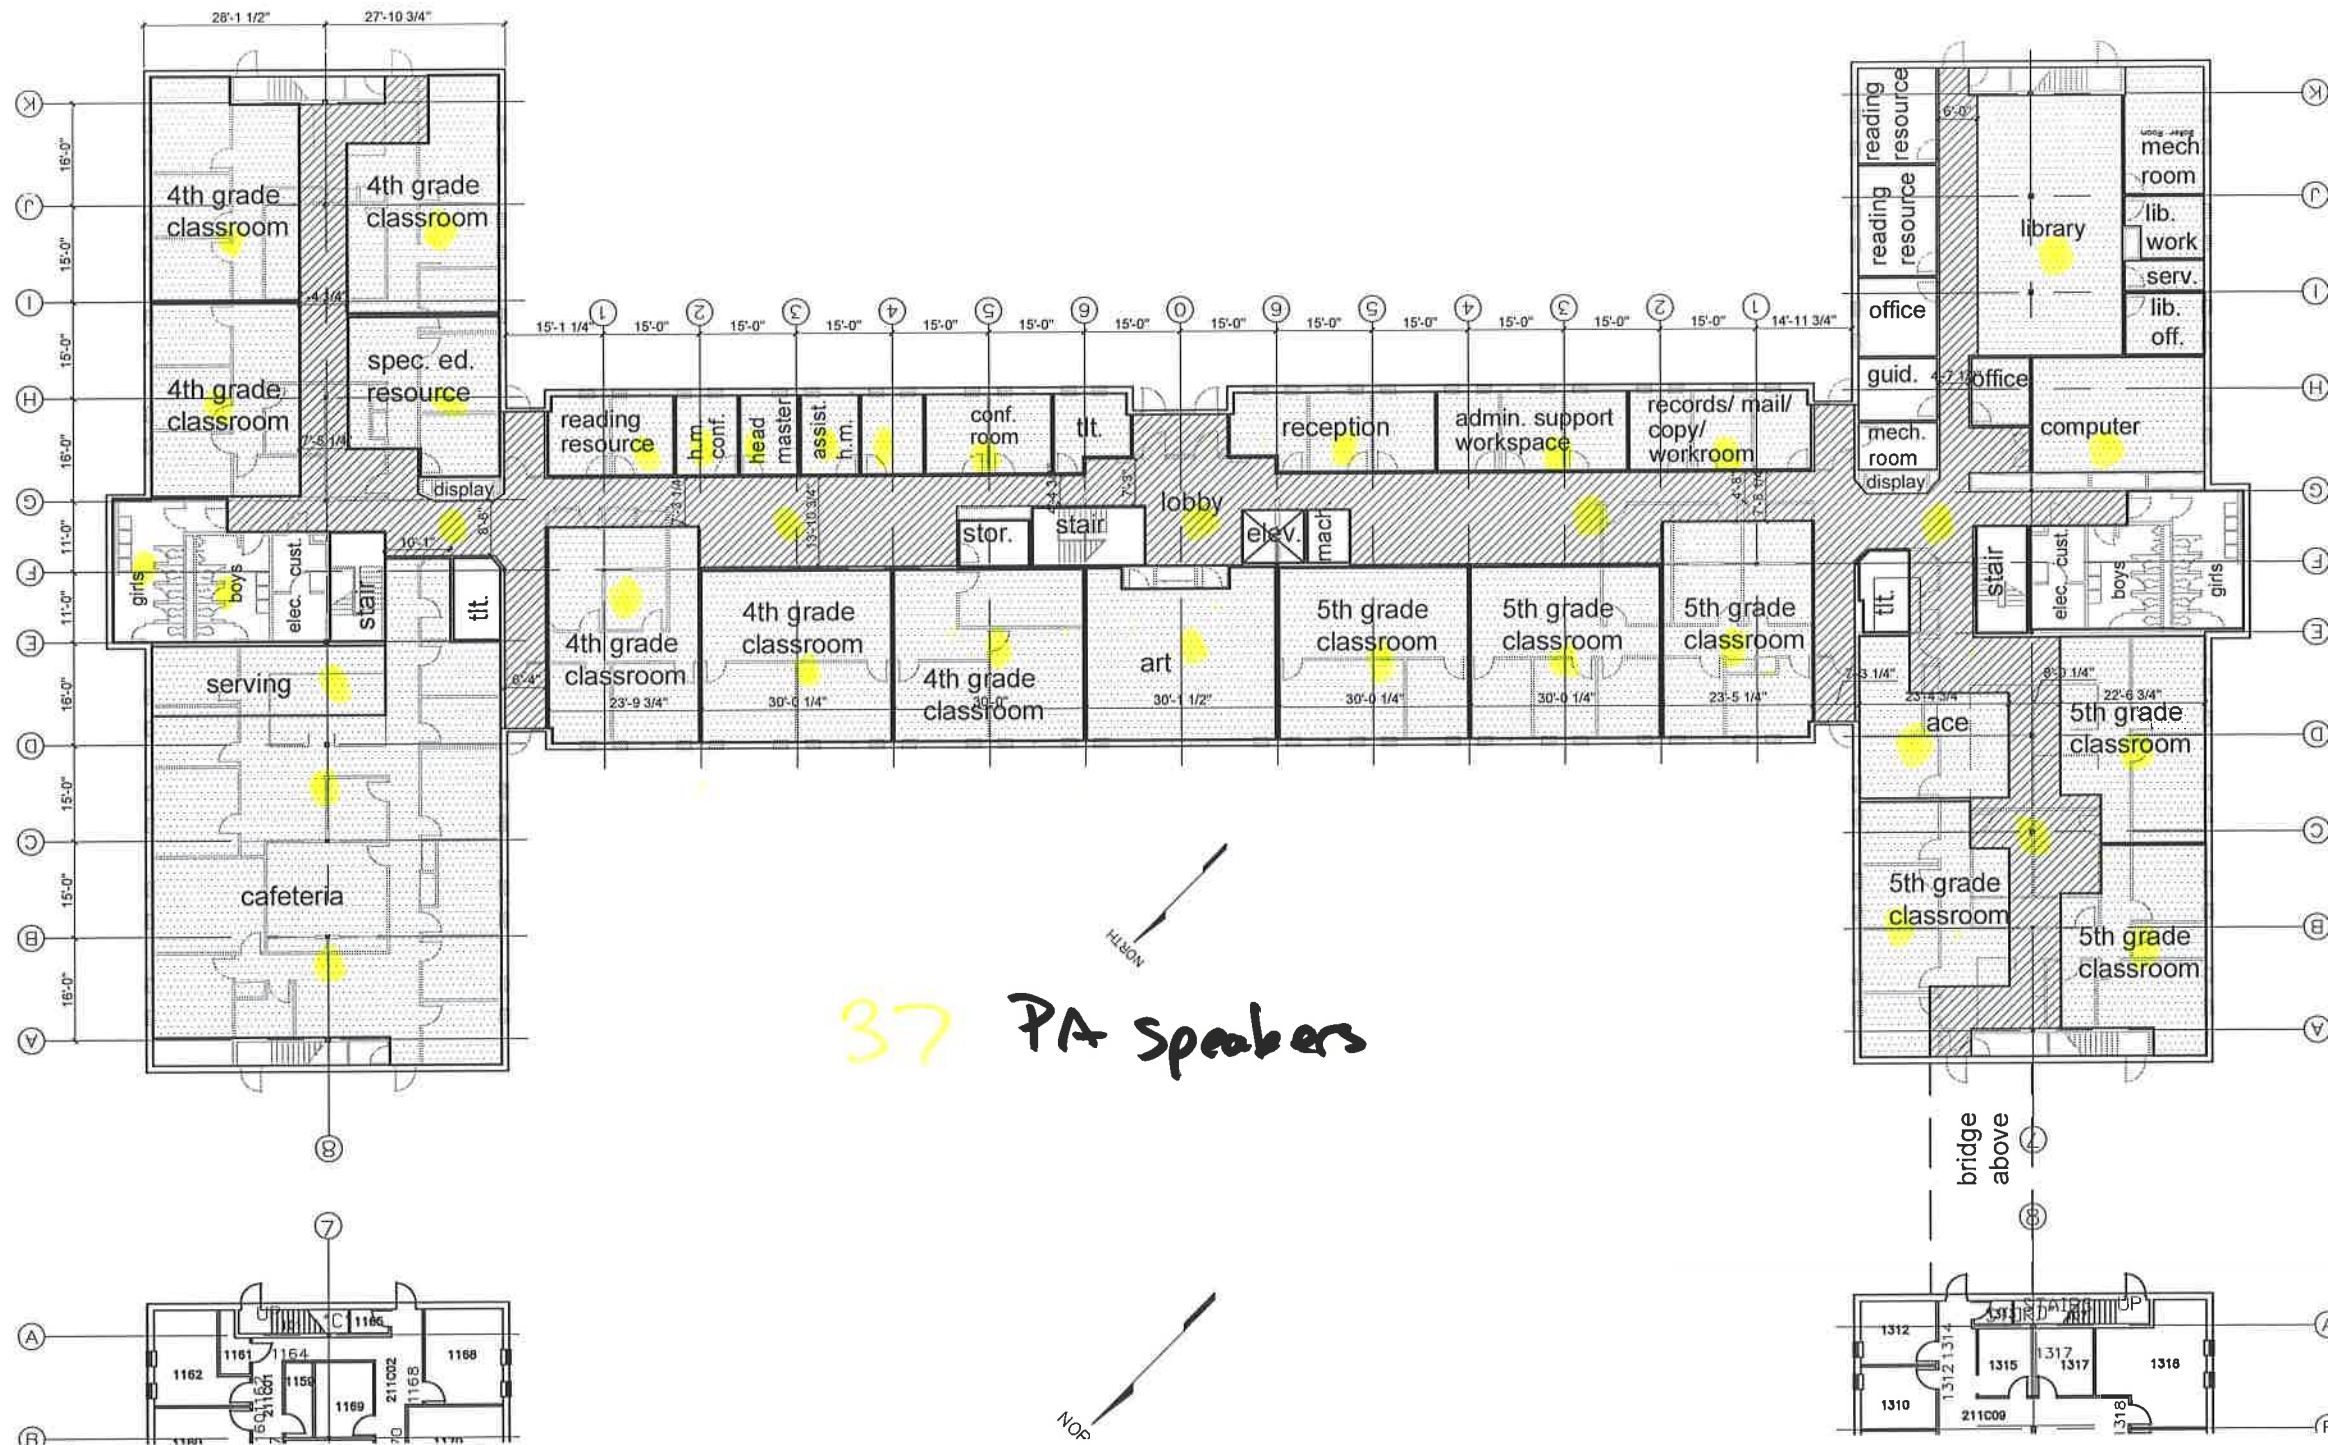

FIRST FLOOR PLAN
 SCALE: 1" = 30'-0"
 0 15' 30' 60'