


Blg 22

Floor Plan

• Access Point Drops

NETWORK Wiring WI-FI

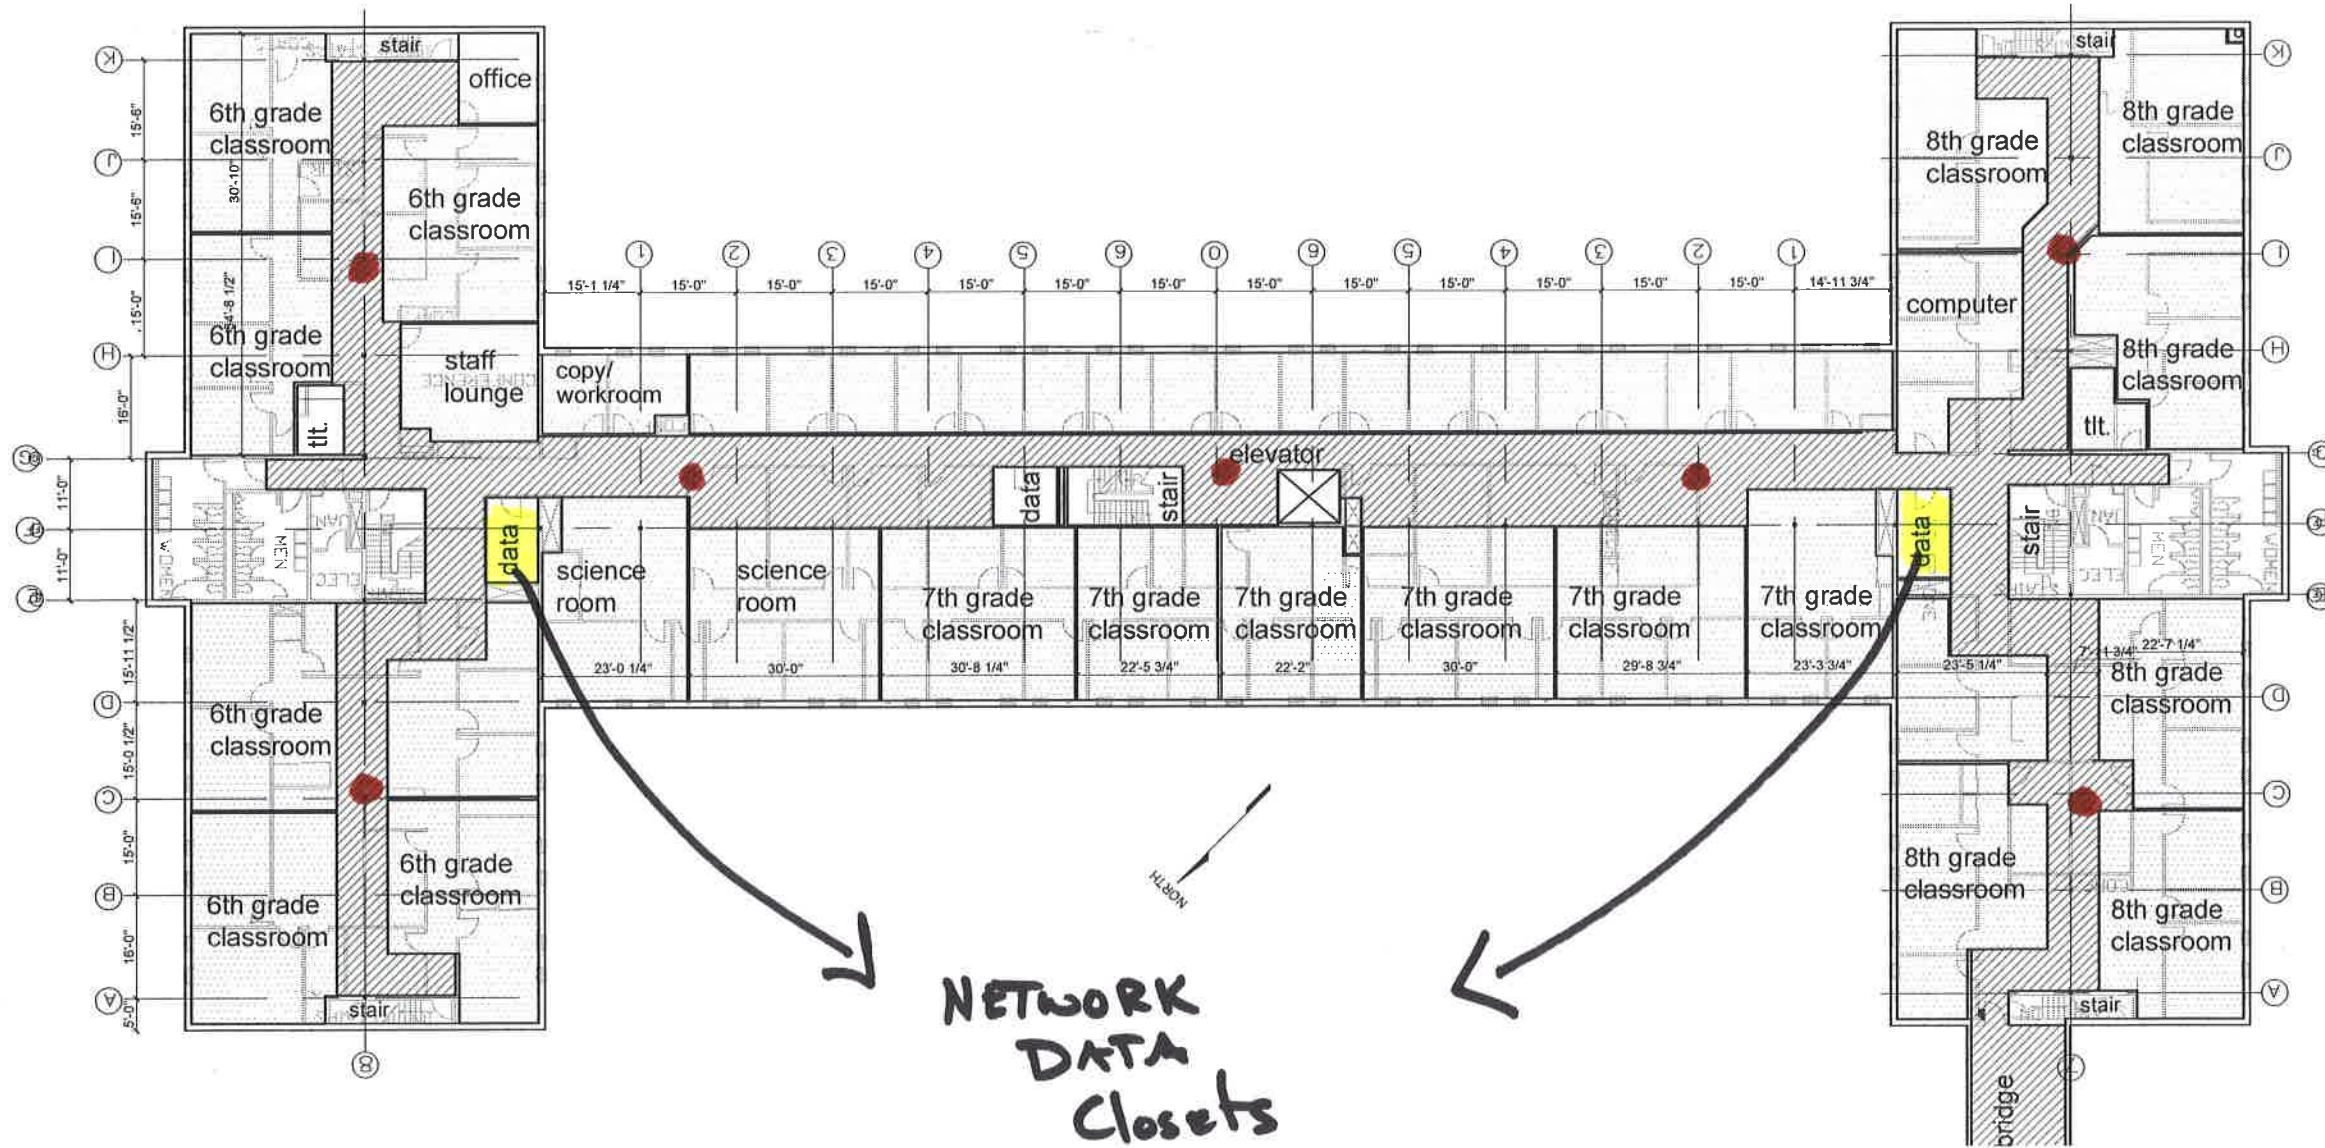

NETWORK DATA Closets

Appox. 10 Drops per classroom [3 jacks gap by yr]
 3 Drops per office
 2 Drops per Access Points

SECOND FLOOR PLAN
 SCALE: 1" = 30'-0"
 0 15' 30' 60'

Bly 22

NETWORK WIRING Floor Plan

WI-FI



Access Points

FIRST FLOOR PLAN
 SCALE: 1" = 30'-0"
 0 15' 30' 60'